

2302 Brockett Road  
Tucker, Georgia  
30084  
770 934 0944  
770 934 0945

**POWER PLAN**

**WASTE MANAGEMENT  
HAULING FACILITY  
HIGHWAY 17  
HARDEEVILLE, SC**


NO.	REVISIONS

DATE: 11/1/2017

PROJECT No. 3E17-068

SHEET NO.

**E2**

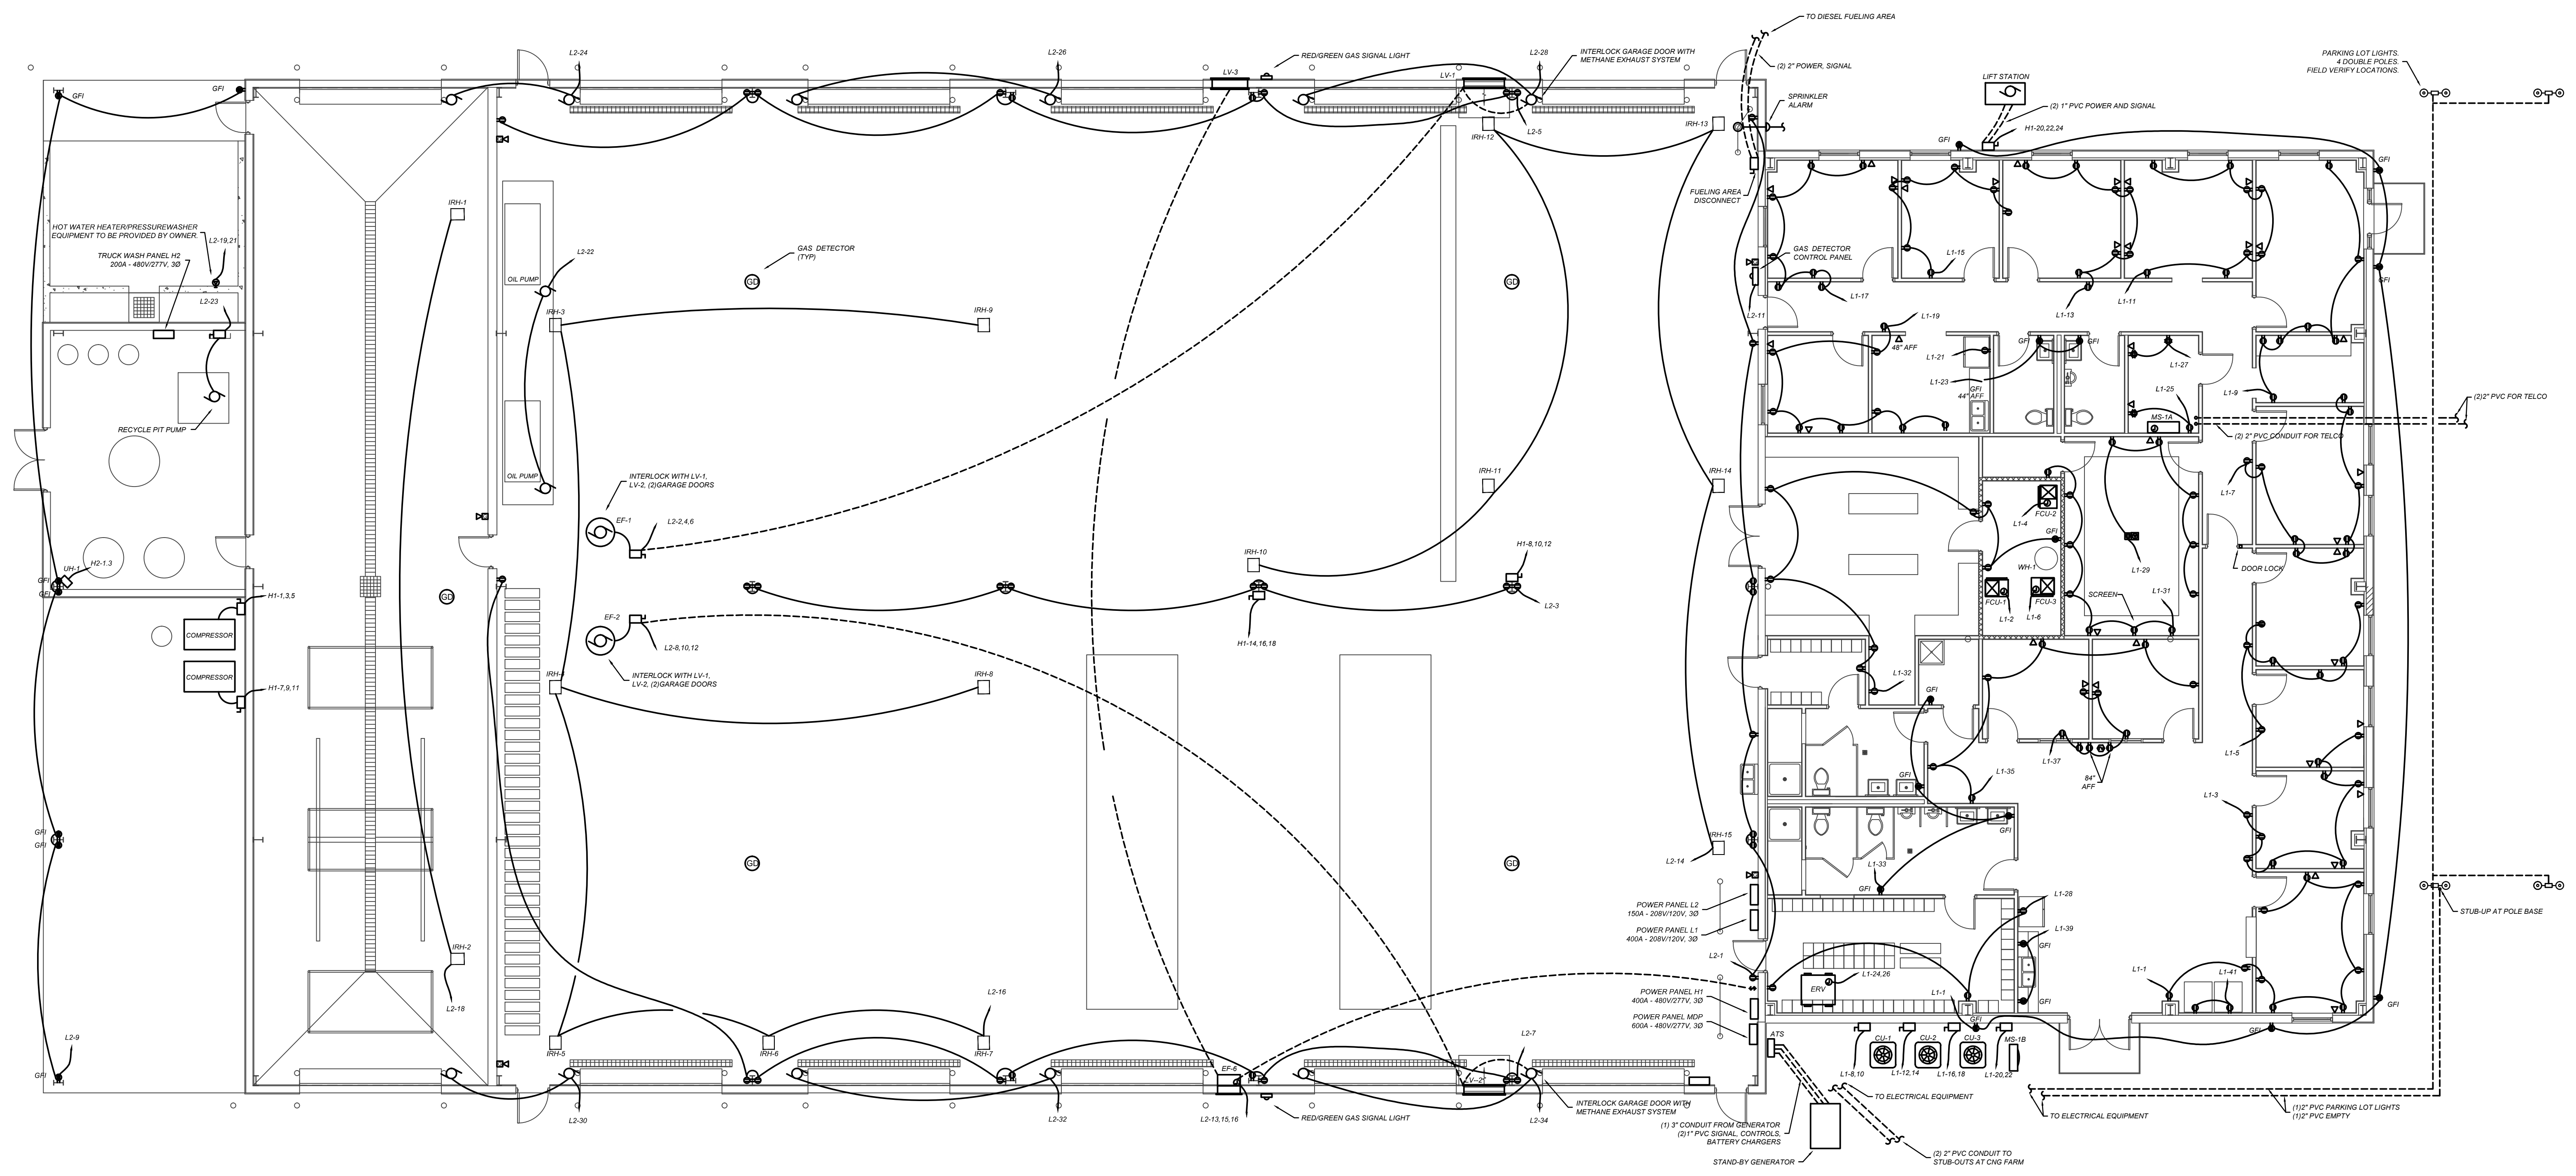

**1**  
**E2** **POWER PLAN**  
1/8"=1'