

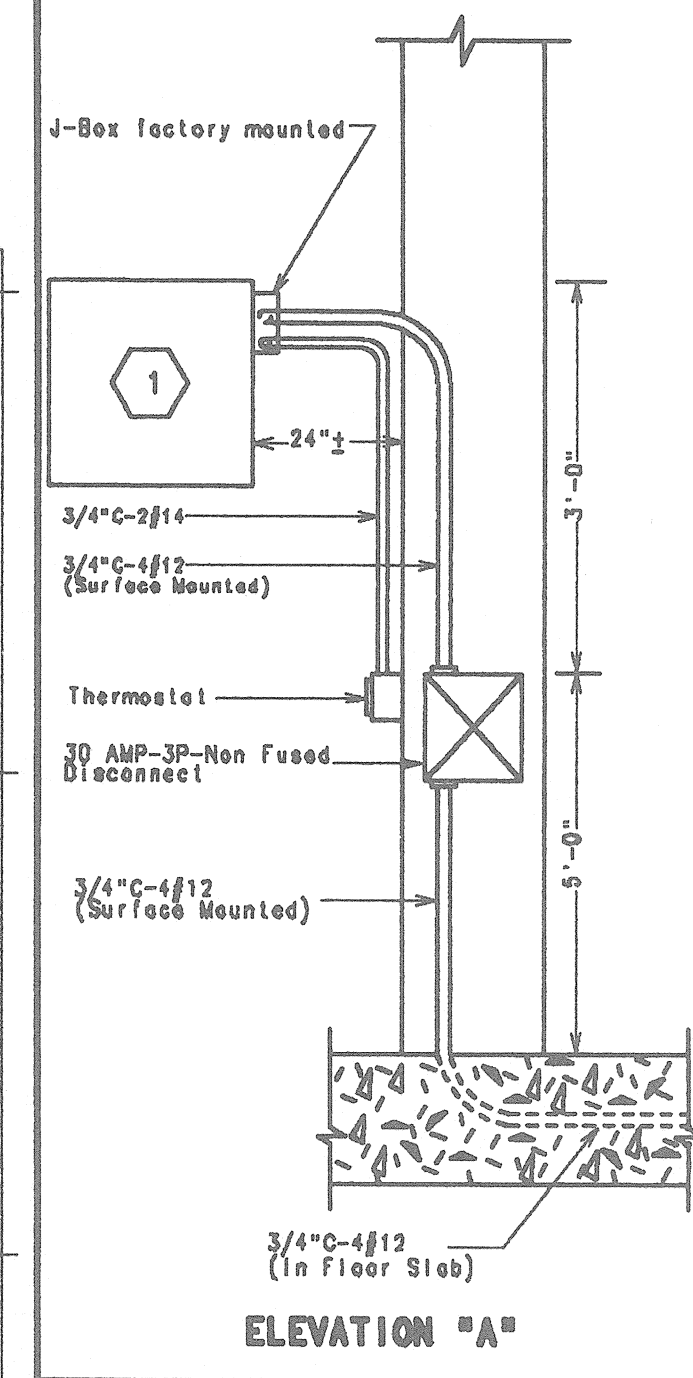


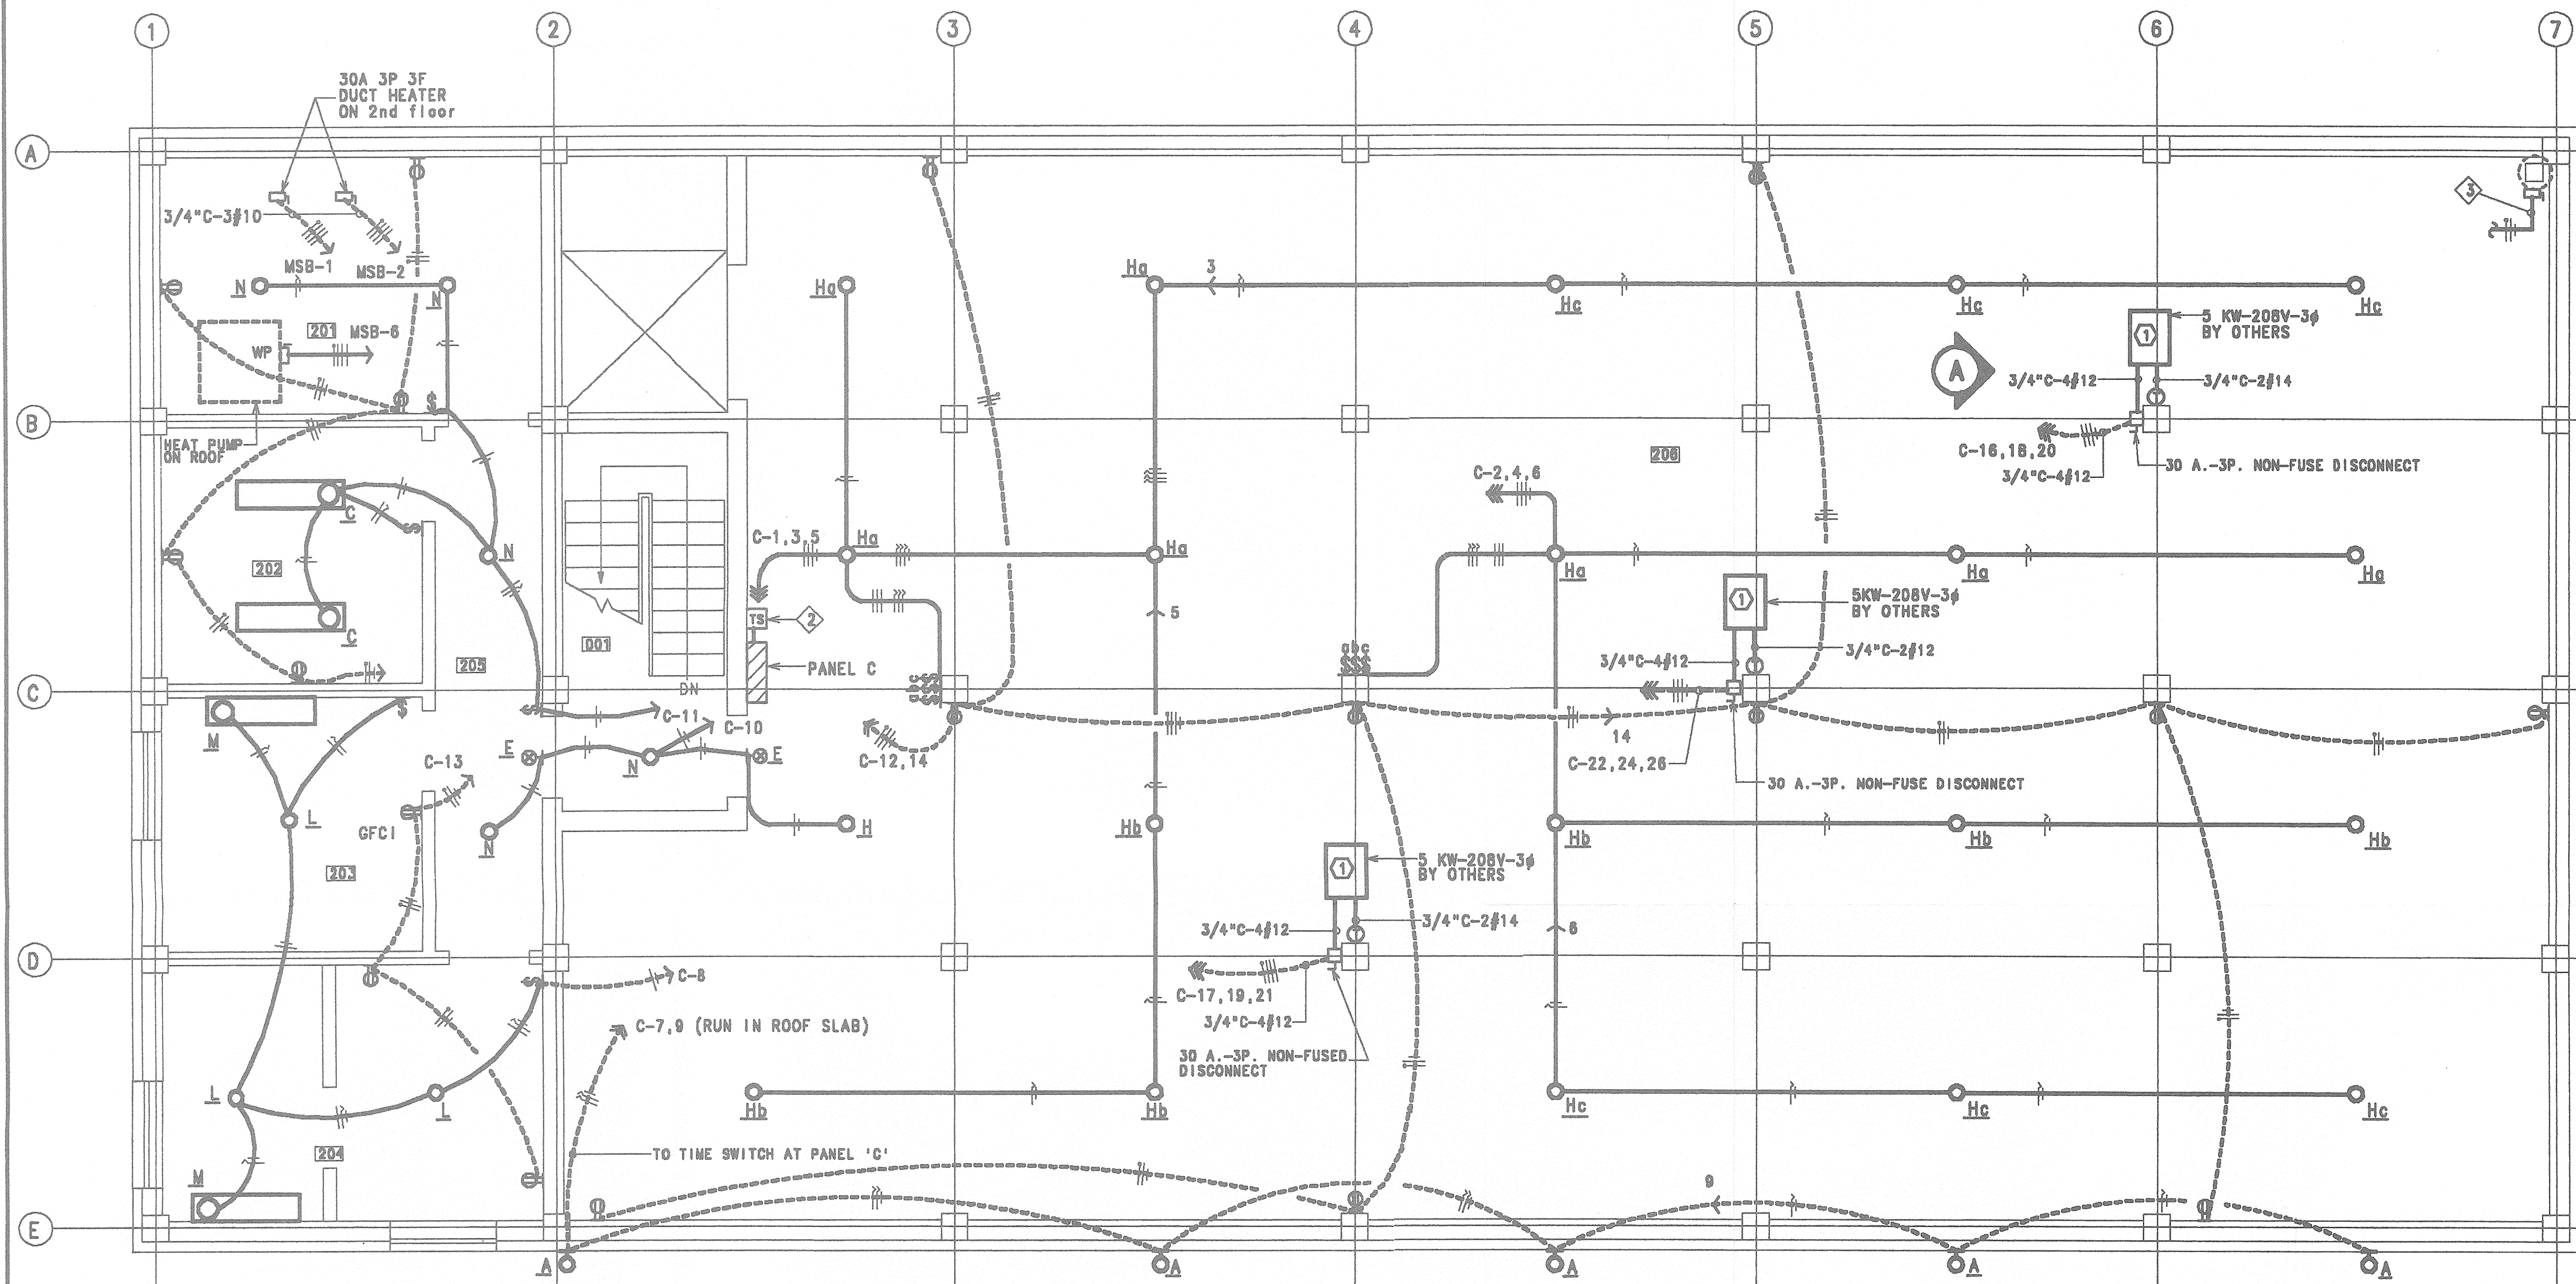

ROOM SCHEDULE	
201	Mechanical Equipment Room
202	Files
203	Men's Toilet
204	Women's Toilet
205	Corridor
206	Warehouse Area
001	Stairs

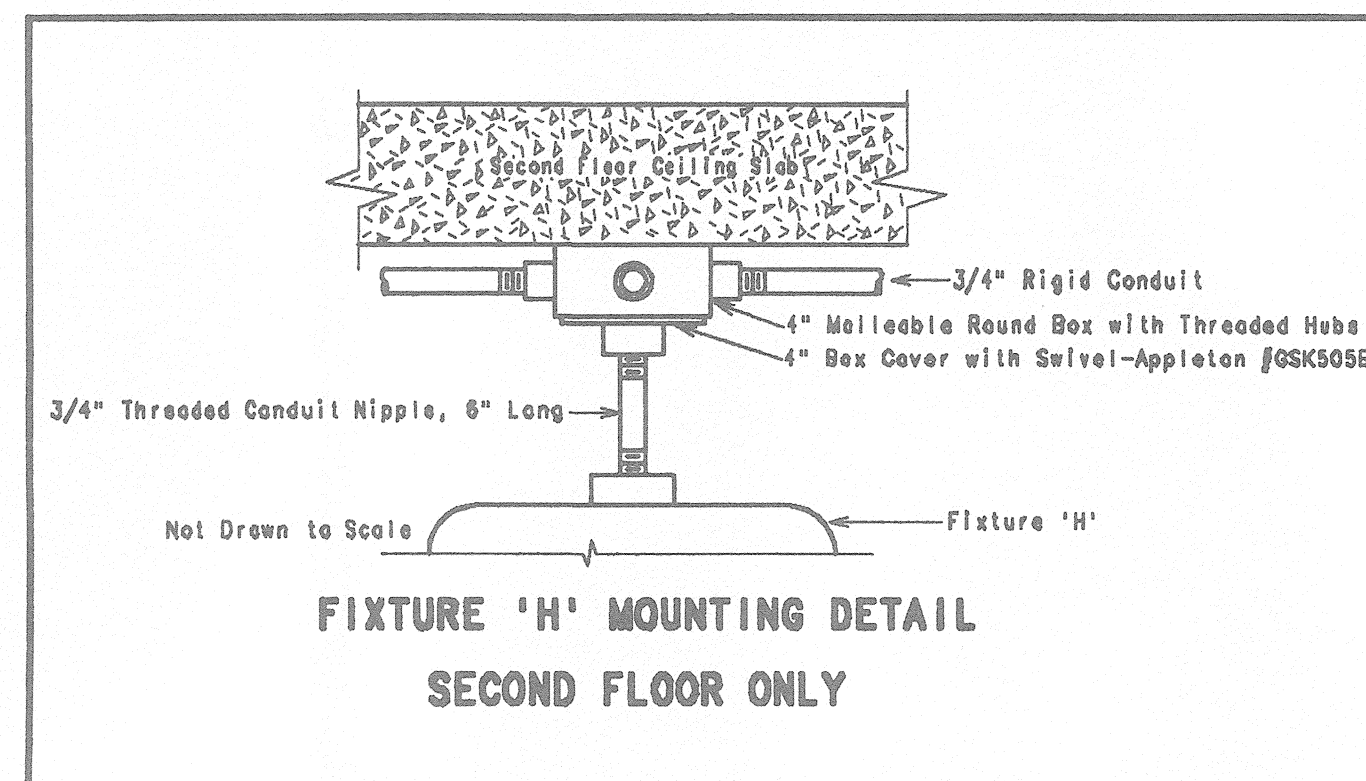

ELECTRICAL SHEET NOTES:

- 1 Second floor warehouse lighting conduit shall be run exposed. Light switches for type 'H' fixture circuits shall be in surface mounted cast tapped or hub device boxes. All other boxes for light switches shall be steel and recessed.
- 2 Time switch shall be DPST for two circuits.
- 3 Down to switch in paint spray booth - refer to sheet E-4.

SECOND FLOOR PLAN-LIGHTING & POWER

OFFICE AND WAREHOUSE FOR ATLANTIC FOOD COMPANY

REVISIONS		JOB. NO.	DATE	DRAWING NO.
DATE				
		DRAWN BY	SCALE	E-3
			1/4"=1'-0"	