

- 1 RUN 1/2" CONDUIT FROM THIS LOCATION TO ELECTRICAL ROOM. (COORDINATE EXACT LOCATION WITH PA SYSTEM)
- M MOTION DETECTOR-OPERATE LIGHT AND TOILET EXHAUST FAN
- 2 LIGHT OPERATE FROM TIMER AND PHOTOCELL (SERIES CONNECTION).



FLOOR PLAN-LIGHT

1/4"=1'-0"

EMERGENCY LIGHT NOTES:


1. THE BRANCH CIRCUIT FEEDING THE EMERGENCY LIGHT AND EXIT LIGHT SHALL BE THE SAME BRANCH CIRCUIT AS THAT SERVING THE NORMAL LIGHTING IN THE AREA AND CONNECTED AHEAD OF ANY LOCAL SWITCHES AS PER NEC CODE 700-12(E).
- a. EMERGENCY AND EXIT LIGHTS CONNECTED TO CIRCUITS CONTROLLED BY TIME CLOCK, OR PHOTOCELL SHALL HAVE BYPASS MEANS TO BE CONTINUOUSLY ENERGIZED WHEN CIRCUIT IS ACTIVE.
- b. CIRCUIT WITH EMERGENCY AND EXIT LIGHTS WITH NO SWITCH, TIME CLOCK OR PHOTOCELL SHALL BE PROGRAMMED TO OPERATE CONTINUOUSLY.

**WALTON COUNTY
SPLASH PARK
BETWEEN, GEORGIA**

SHEET TITLE:
FLOOR PLAN -LIGHTS
FIXTURES SCHEDULE, SPEC.
PRINTED: 09/27/19

NUMBER:

E-2

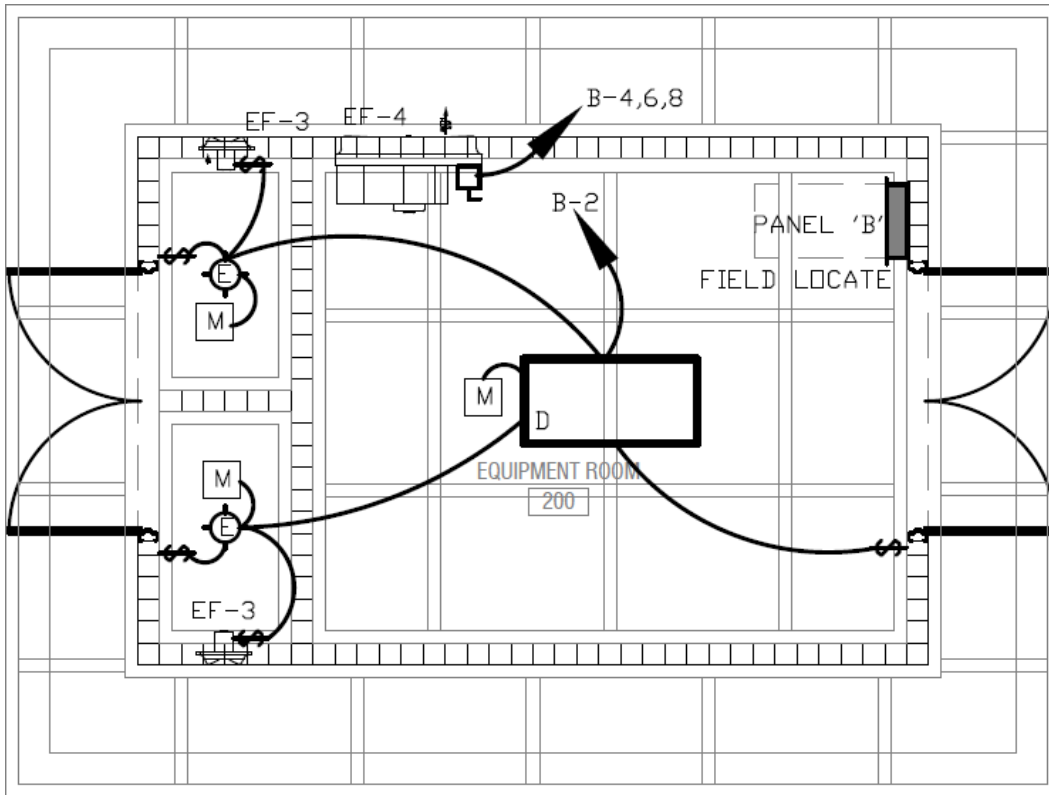

EQUIPMENT ROOM PLAN-LIGHT

1/4"=1'-0"

SEE VORTEX DRAWINGS FOR THE EQUIPMENT

LIGHT FIXTURE SCHEDULE								
Symbol	Label	Manufacturer	Catalog Number	DESCRIPTION	Number Lamps	Lumens Per Lamp	Light Loss Factor	Wattage
⊕	A	Cree Inc TECHNOLED	S-DL4-11L-40K	4-Inch Downlight, 11L CXB1512 Lumen Package, 4000K, Medium Distribution WET LOCATION	1	961.8757	0.95	11.18
			w_S-DL4T-M-SS-C S-DL4TL-SPDL1ECD-4-40K			1245		15
⊙	B	TECHNOLED	C-WM-A-WLHR-12L-40K-MB	CREE-LED EXTERIOR LIGHT WET LOCATION WITH PHOTOCELL		1200		22
			TL-MWP1-20W-H-50K			2200		20
□	C	Ceralux TECHNOLED	CRS-3555-2x2-LED-8-50K	2X4 LED SURFACE MOUNTED 4000K, DOOR/HOUSING APPROVED BY THE OWNER. WET LOCATION	1	5200	0.95	47
			052L-UNV-P56-X8 LP-2X2-40-50-DS-LP-SRFC			4400		40
▭	D	Ceralux TECHNOLED	CRS-3555-2x4-LED-8-50K	2X4 LED SURFACE MOUNTED 4000K, DOOR/HOUSING APPROVED BY THE OWNER. WET LOCATION	1	7800	0.95	75
			078L-UNV-P56-X8 LP-2X4-72-50-DS-LP-SRFC			4400		75
⊕	E	LARSON	VPLED-CRNM-LED10W			1050		
⚡		EXITRONIX	LED-52-WH-G2	Medium Distribution EXITRONIX LED-52 SERIES EMERGENCY LIGHT				1.1
⚡		EXITRONIX	VLED-EL90-G2	EXITRONIX VLED SERIES COMBINATION EXIT AND EMERGENCY LIGHT				
⊗		EXITRONIX	902E/903/E-U-WB-RM-G2	EXITRONIX 900 SERIES EXIT LIGHT				