

ACCUBID OFFICE BUILDING




PROJ. NO.
2007

SCALE
1/8" = 1'-0"
DATE
06/01/07

DRAWING NO.
E.1.1

FUTURE OFFICE BUILDING

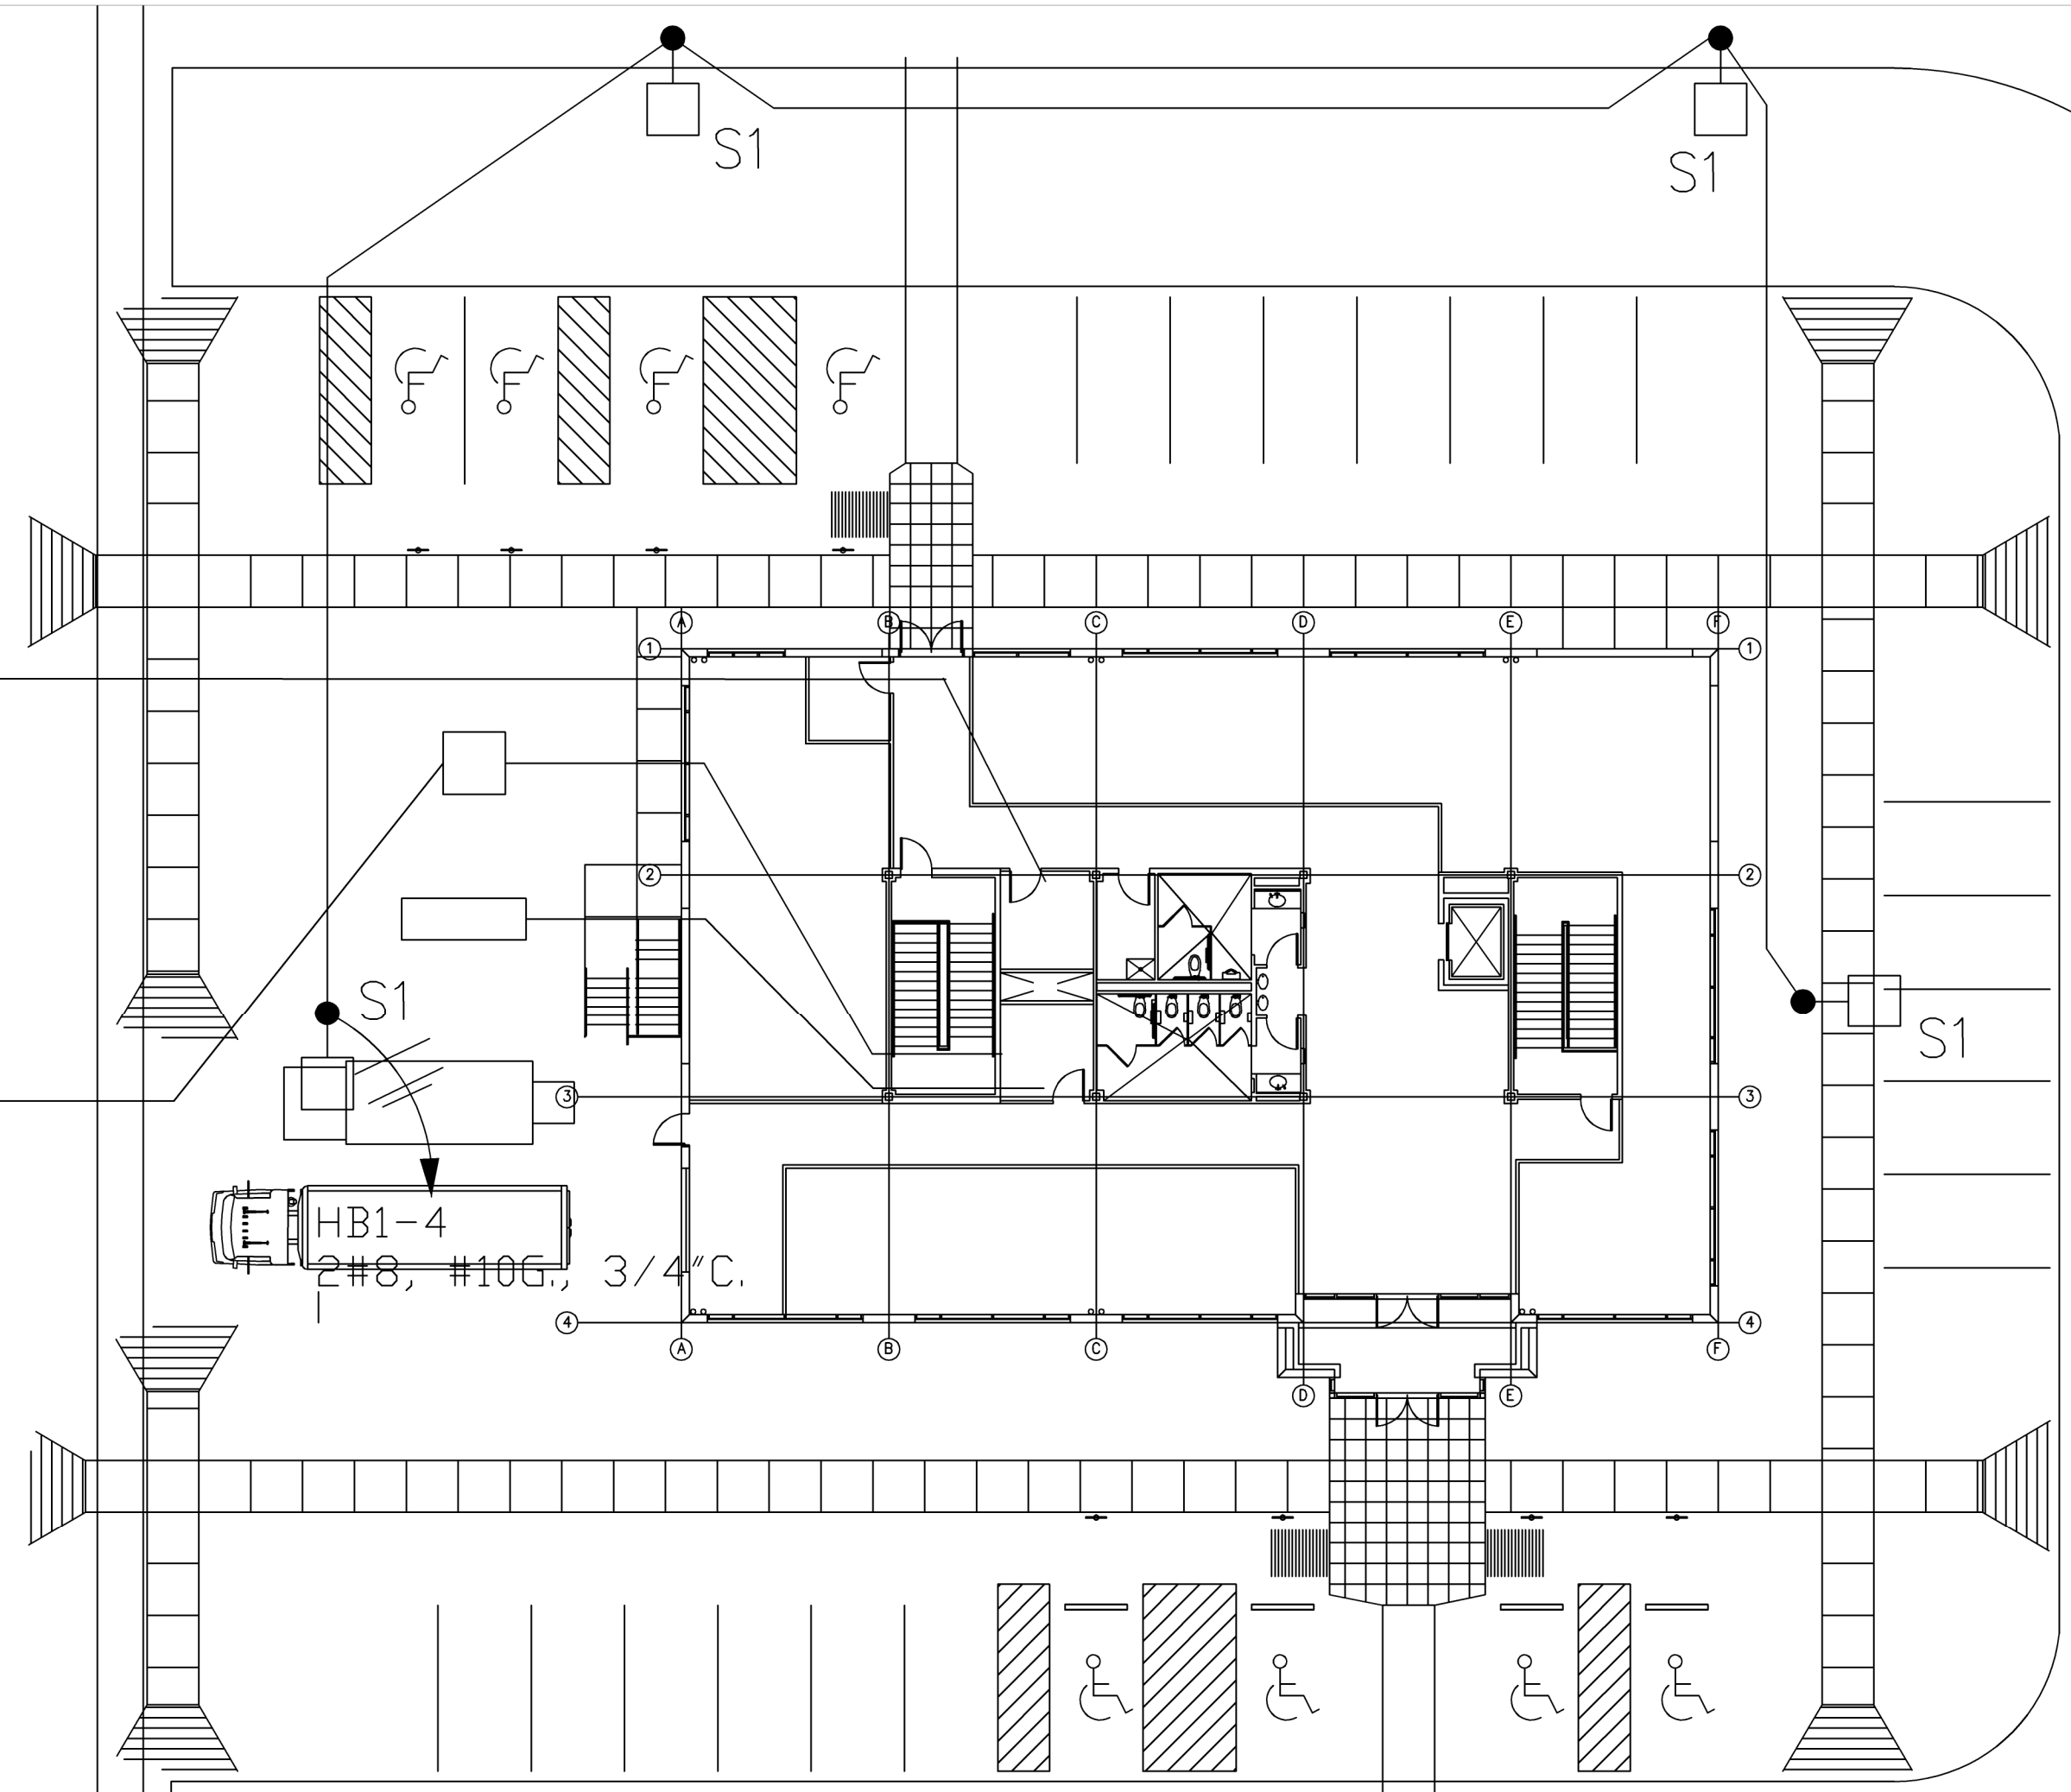

HB1-4
2#8, #10G., 3/4" C.

HB1-2
2#8, #10G., 3/4" C.

REFER TO LIGHT POLE BASE
DETAIL ON SHEET E6.2 (TYP.)

ELECTRICAL SITE PLAN - POWER/LIGHTING

SCALE: 1/16" = 1'-0"