



ACCUBID OFFICE BUILDING

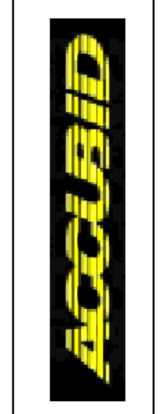

PROJ. NO.  
2007

SCALE  
3/16" = 1'-0"  
DATE  
06/01/07

DRAWING NO.  
E 4.2

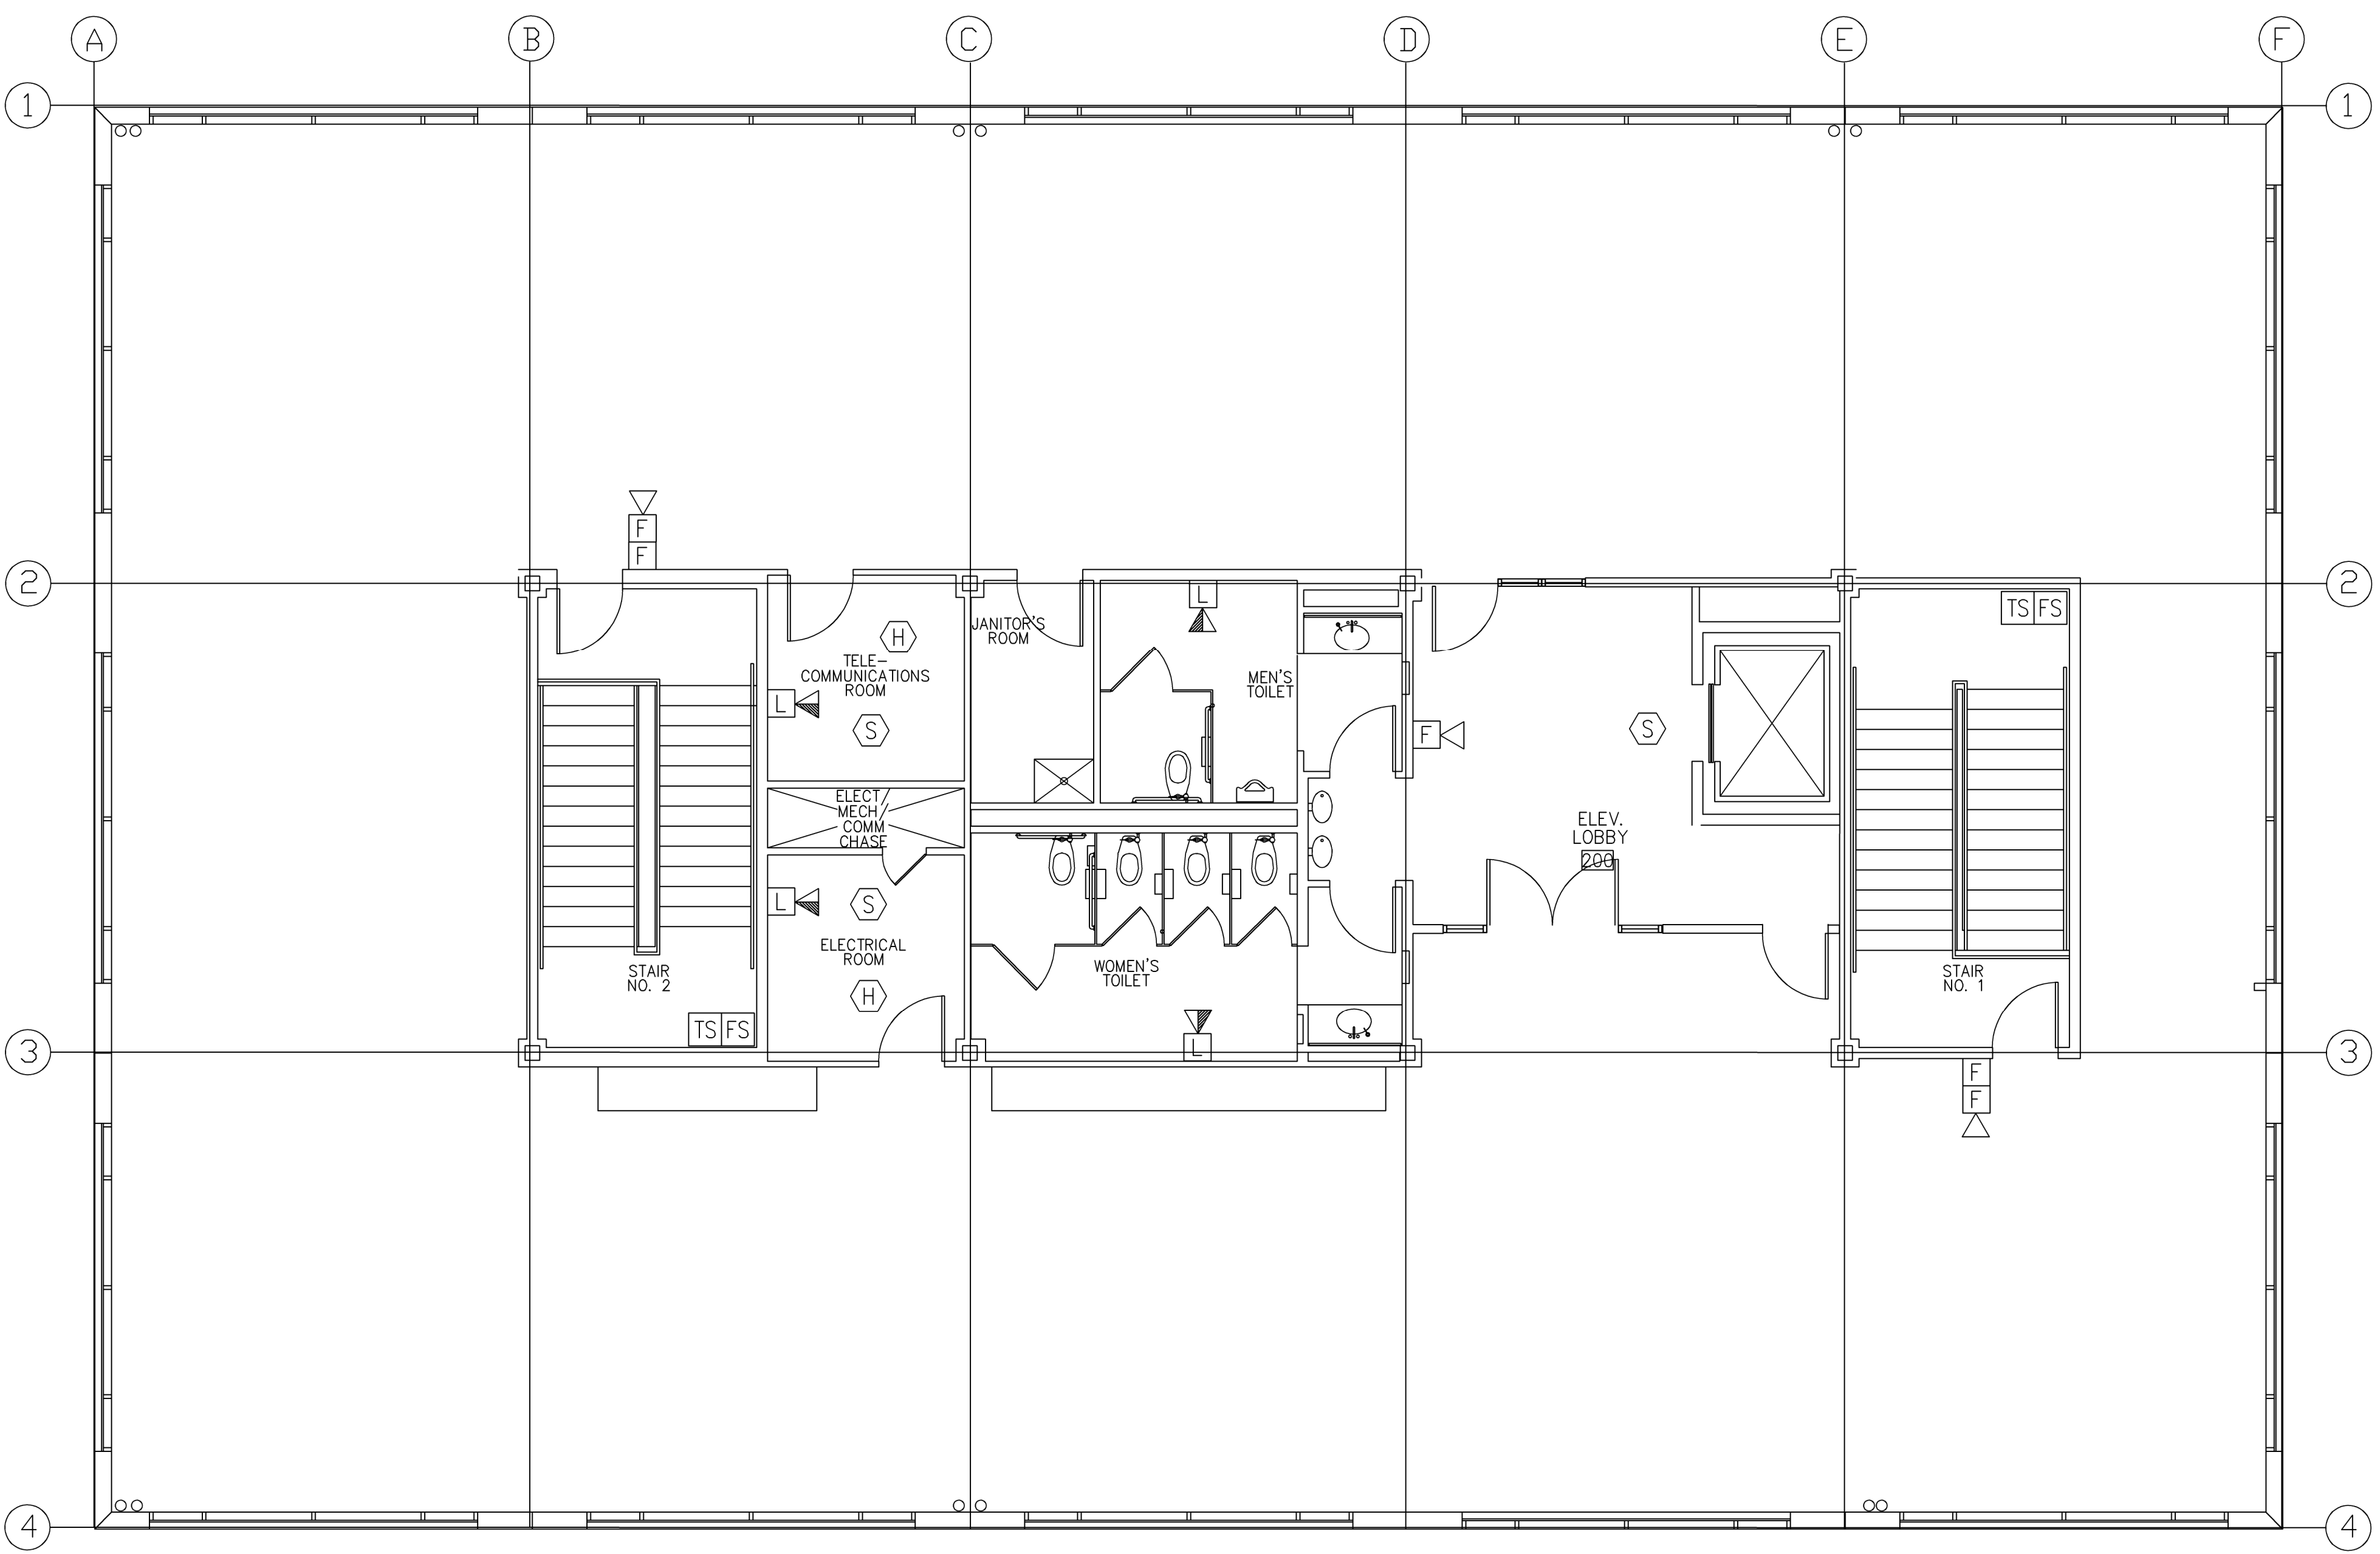

TYPICAL FLOOR ( 2ND TO 3RD) PLAN - FIRE ALARM SYSTEM

SCALE: 3/16" = 1'-0"