



ACCUBID OFFICE BUILDING

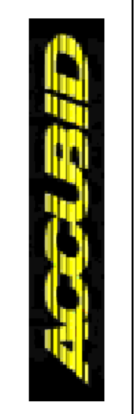

PROJ. NO.
2007

SCALE
3/16" = 1'-0"
DATE
06/01/07

DRAWING NO.
E 4.3

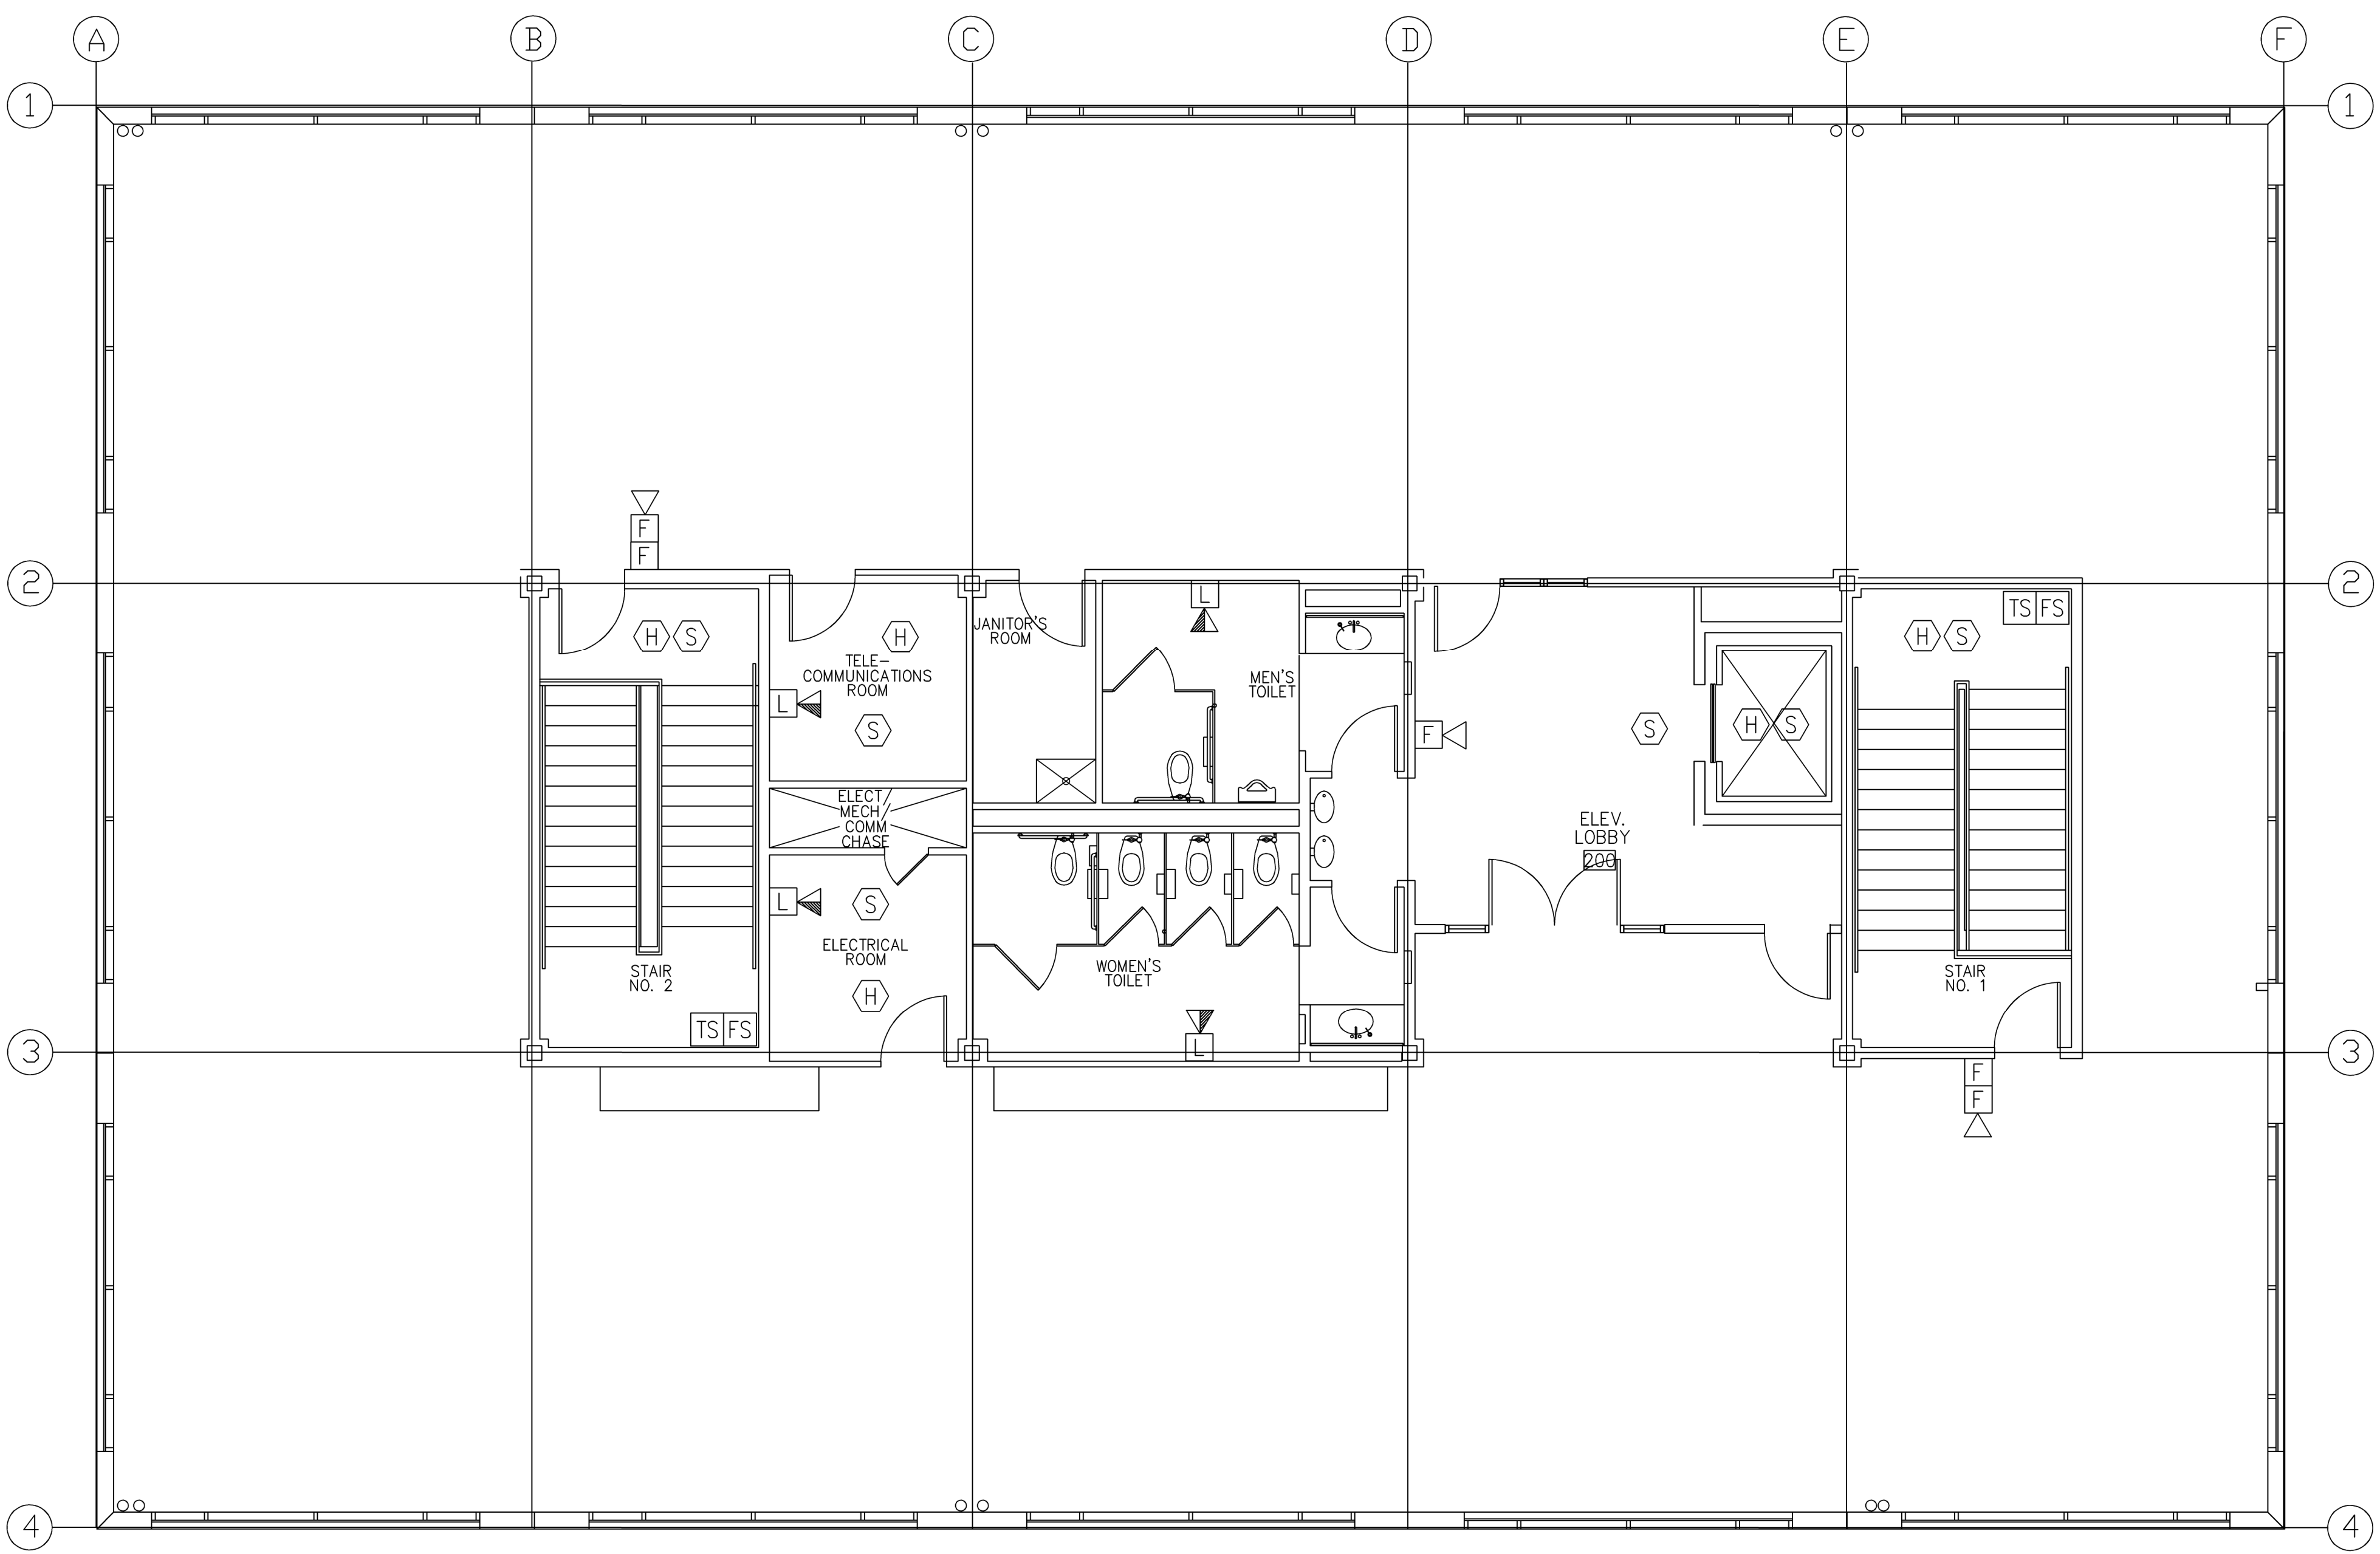

FOURTH FLOOR PLAN - FIRE ALARM SYSTEM

SCALE: 3/16" = 1'-0"

